

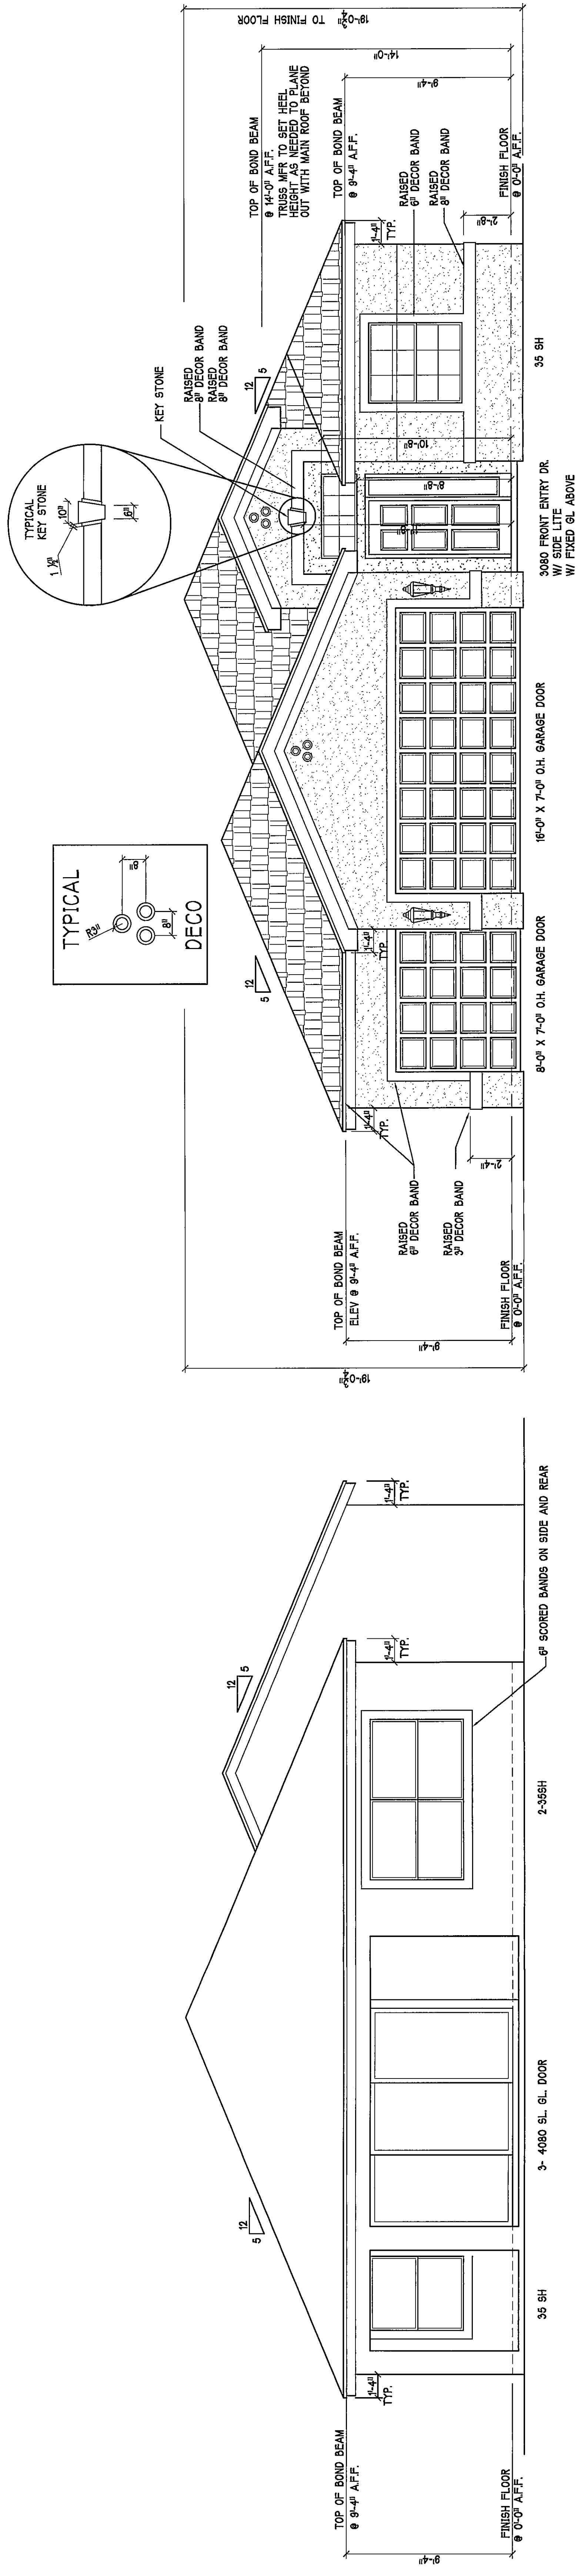
 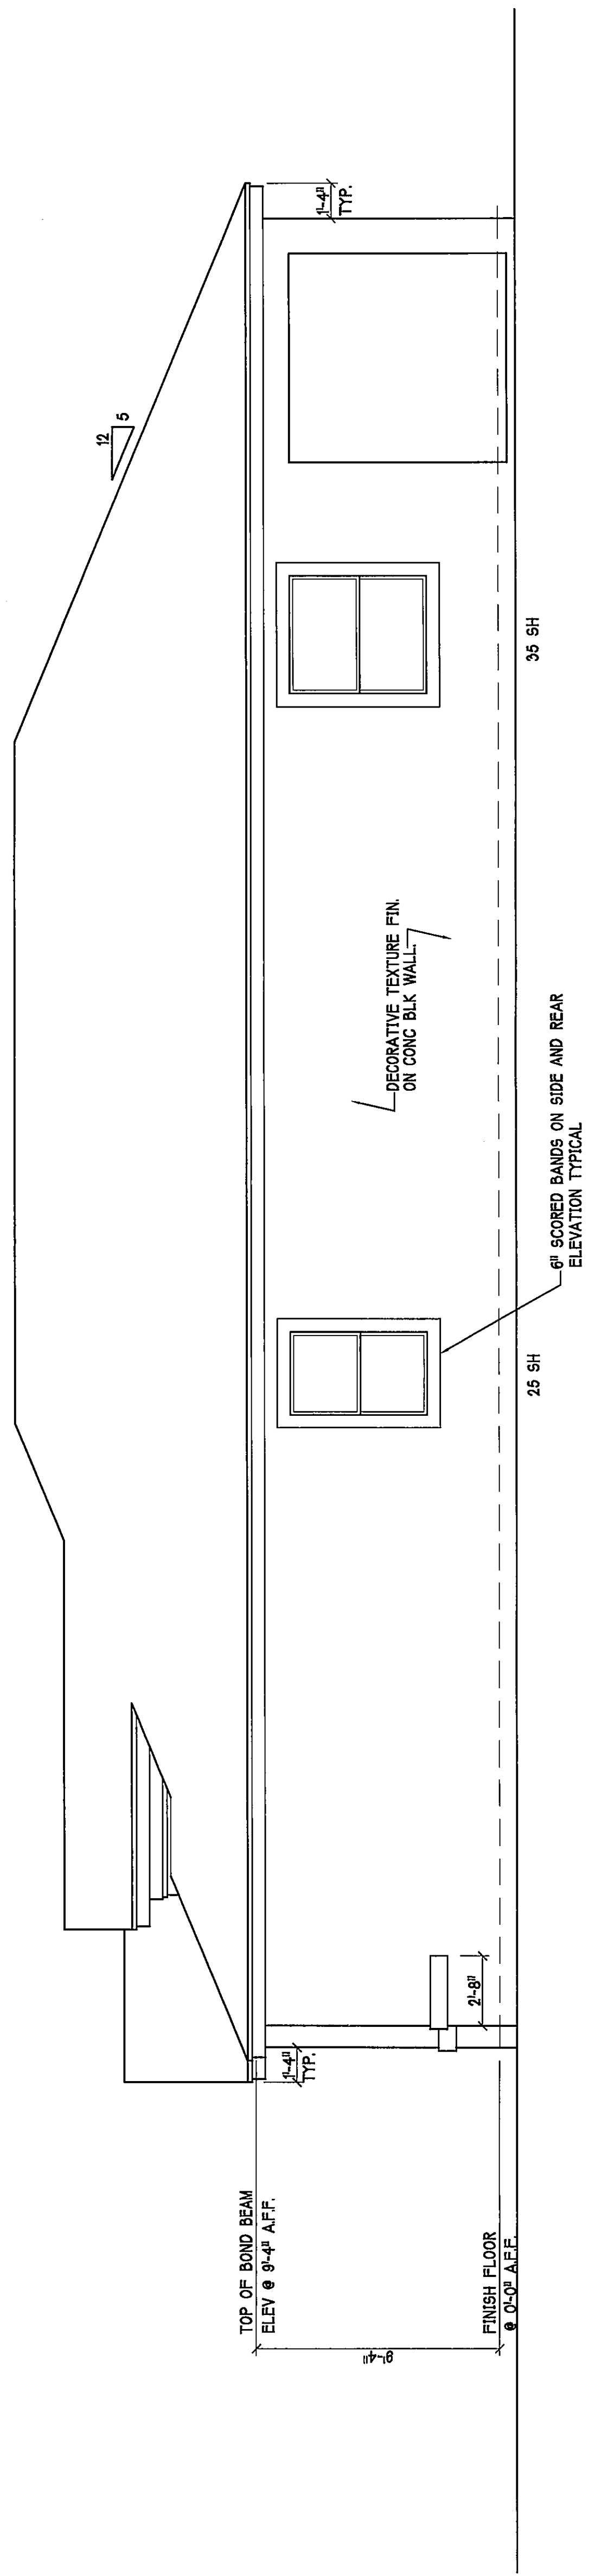


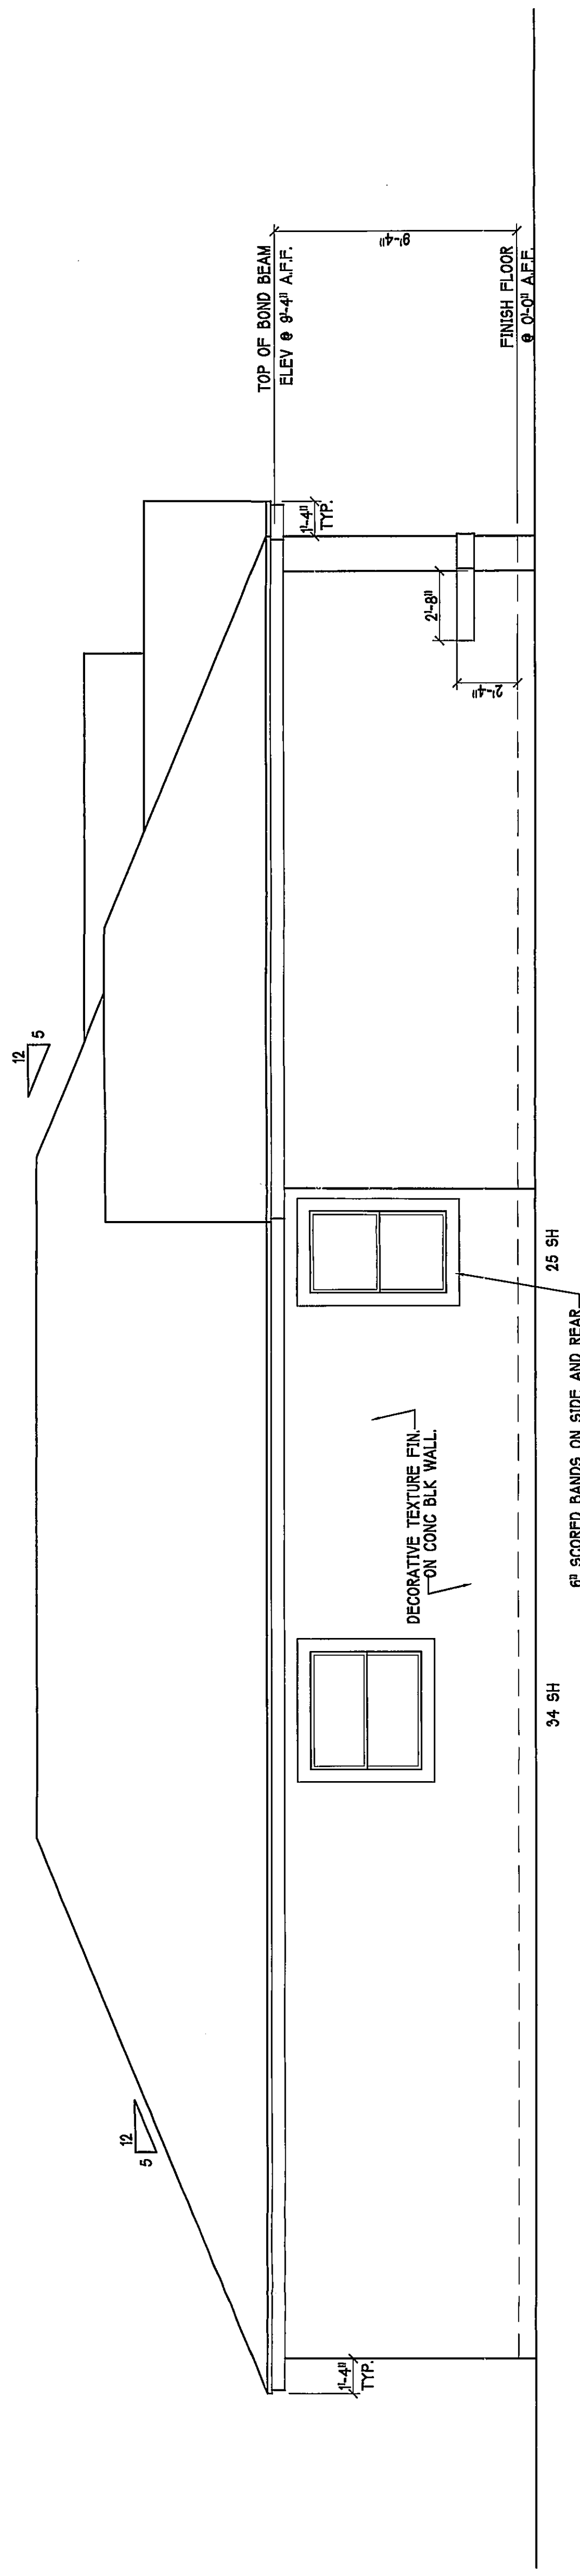


**NOTE: CROWN BANDING MUST RETURN
10'-0" ON SIDE ELEVATION & RETURN
TO ENTRY**



REVIEWED
FOR CODE COMPLIANCE
CAPE CORAL BUILDING DIVISION
DATE 8/1/14
BY [Signature]
ALL CONSTRUCTION SHALL BE IN ACCORDANCE WITH THE FLORIDA BUILDING CODE. THE CONTRACTOR SHALL BE RESPONSIBLE FOR OBTAINING ALL NECESSARY PERMITS AND INSURANCE. THE CONTRACTOR SHALL BE RESPONSIBLE FOR OBTAINING ALL NECESSARY PERMITS AND INSURANCE.

PAD FOOTING SCHEDULE				
TYPE	LENGTH	WIDTH	DEPTH	BOTTOM REIN. LONG WAY SHORT WAY
1	2'-6"	2'-6"	1'-0"	3-#5 3-#5
2	3'-0"	3'-0"	1'-0"	4-#5 4-#5
3	3'-6"	3'-6"	1'-0"	4-#5 4-#5
4	4'-0"	4'-0"	1'-2"	5-#5 5-#5
5	5'-0"	5'-0"	1'-2"	6-#5 6-#5

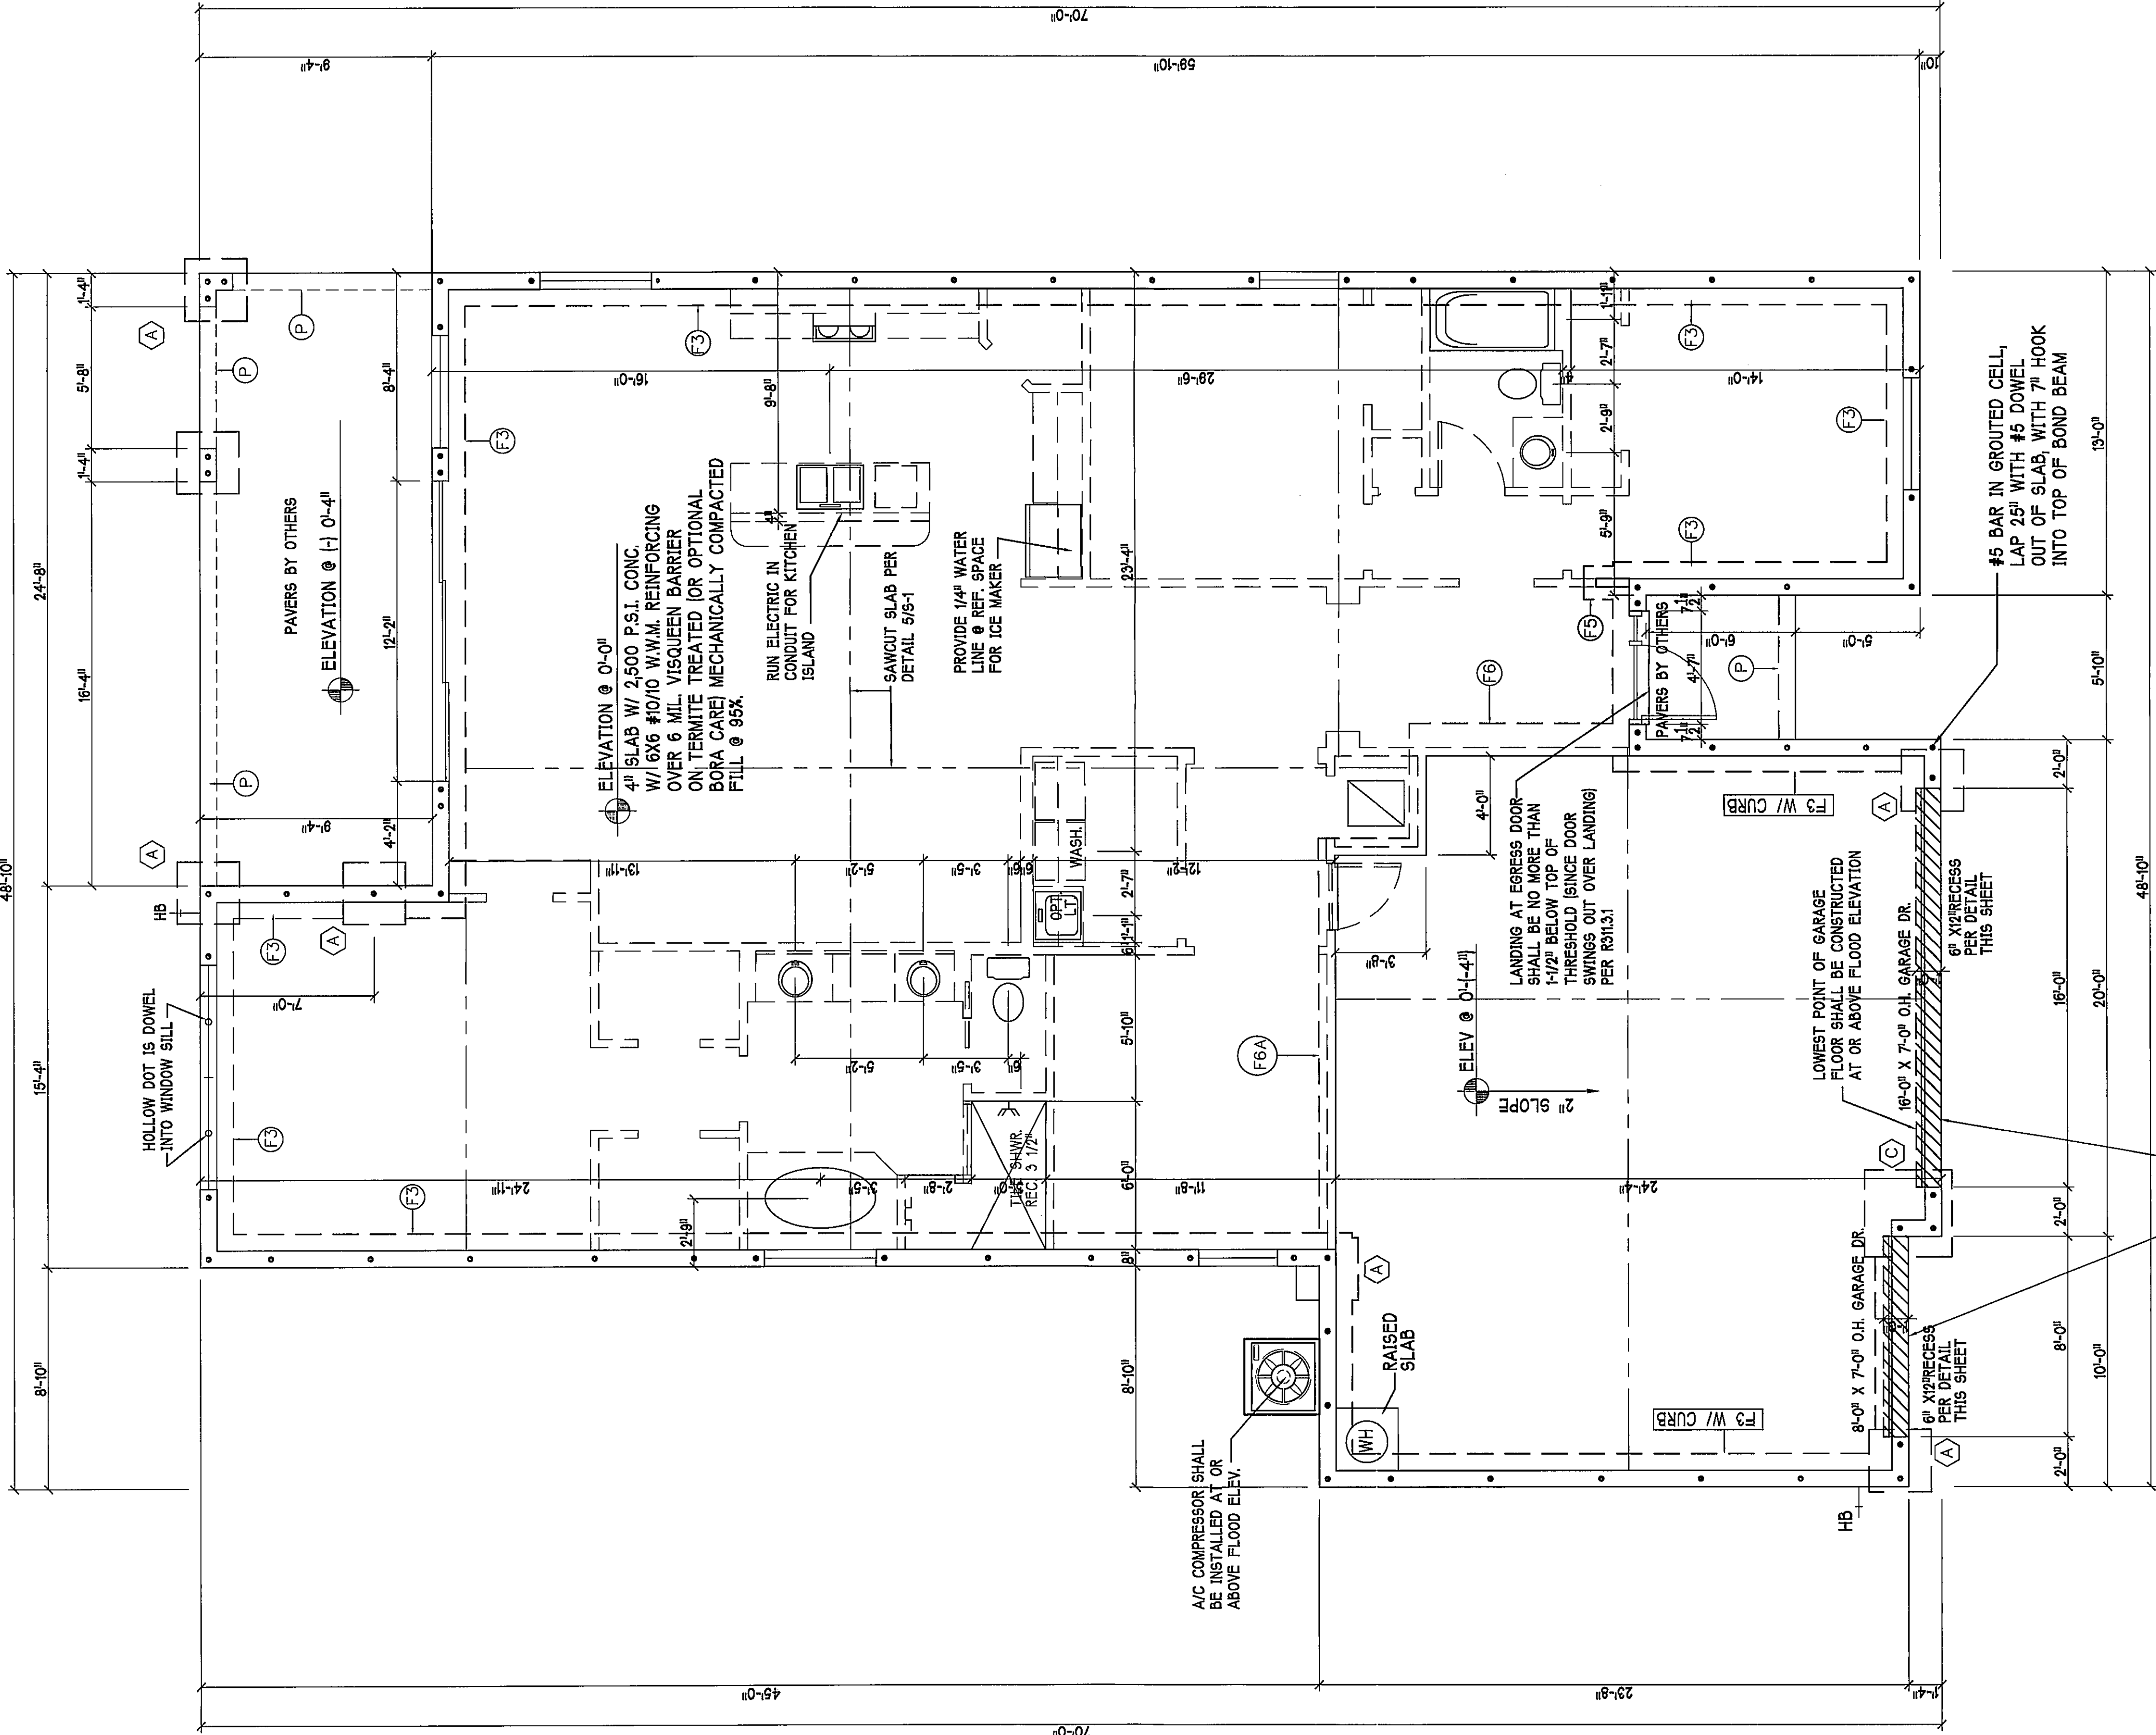

8F8-1B SET AT GARAGE DOOR RECESS, TO 8X8 BOND BEAM W/ 1 #5 TOP @ 9'-4". ADD #5 VERT @ 48" O.C. GROUT ALL SOLID.


FOUNDATION PLAN: SCALE: 1/4"=1'-0"

FOUNDATION PLAN SCALE: 1/4" = 1'-0"


- PLAN NOTES:
- 1) TOP OF GROUND FLOOR SLAB DATUM ELEVATION 0'-0"
 - 2) F# DENOTES CONTINUOUS WALL FOOTING TYPE PER SCHEDULE THIS SHEET.
 - 3) DENOTES REINFORCED CONCRETE FOOTING PER SCHEDULE THIS SHEET.
 - 4) PROVIDE #5 VERTICAL REINFORCING AT DOT LOCATIONS SHOWN ON PLAN FROM FOOTING TO BOND BEAM.
 - 5) ALL DIMENSIONS ARE TO OUTSIDE FACE OF MASONRY WALLS. SOME SLAB EDGES MAY EXTEND BEYOND FACE OF WALL.
 - 6) FOR DIMENSIONS OF ROUGH OPENINGS IN MASONRY WALLS, COORDINATE WITH WINDOW/DOOR SUPPLIER.
 - 7) PROVIDE PRESSURE TREATED BUCKS AT WINDOWS / DOORS PER DETAIL 7/S-1.

PAD FOOTING SCHEDULE


TYPE	LENGTH	WIDTH	DEPTH	BOTTOM REIN. LONG WAY SHORT WAY	REMARKS
1	2'-6"	2'-6"	1'-0"	3-#5 3-#5	-
2	3'-0"	3'-0"	1'-0"	4-#5 4-#5	-
3	3'-6"	3'-6"	1'-0"	4-#5 4-#5	-
4	4'-0"	4'-0"	1'-2"	5-#5 5-#5	-
5	5'-0"	5'-0"	1'-2"	6-#5 6-#5	-

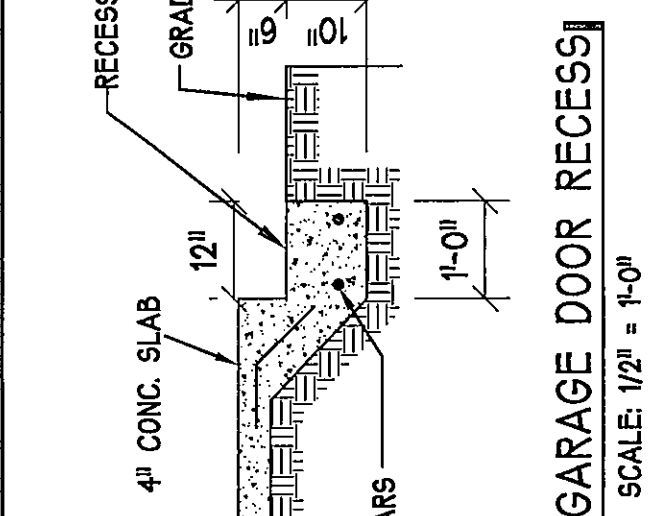


GARAGE DOOR RECESS SCALE: 1/2" = 1'-0"

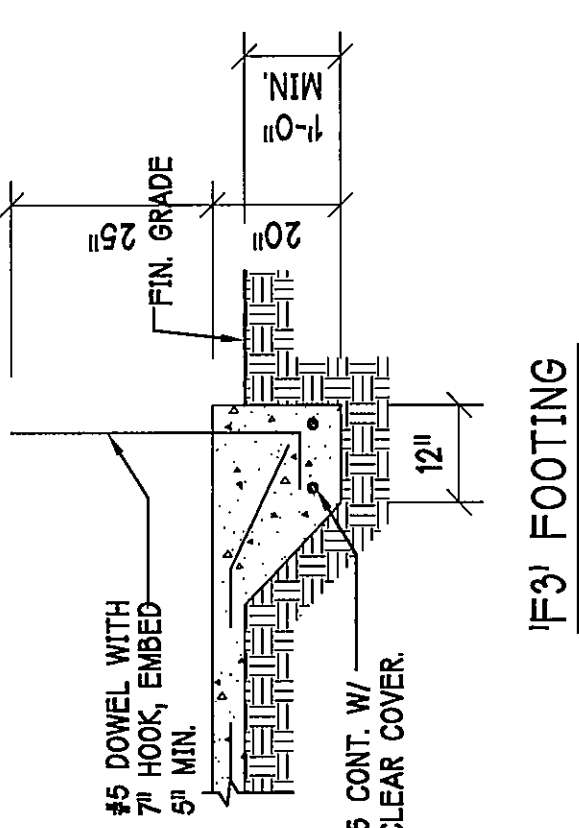


F#3 FOOTING

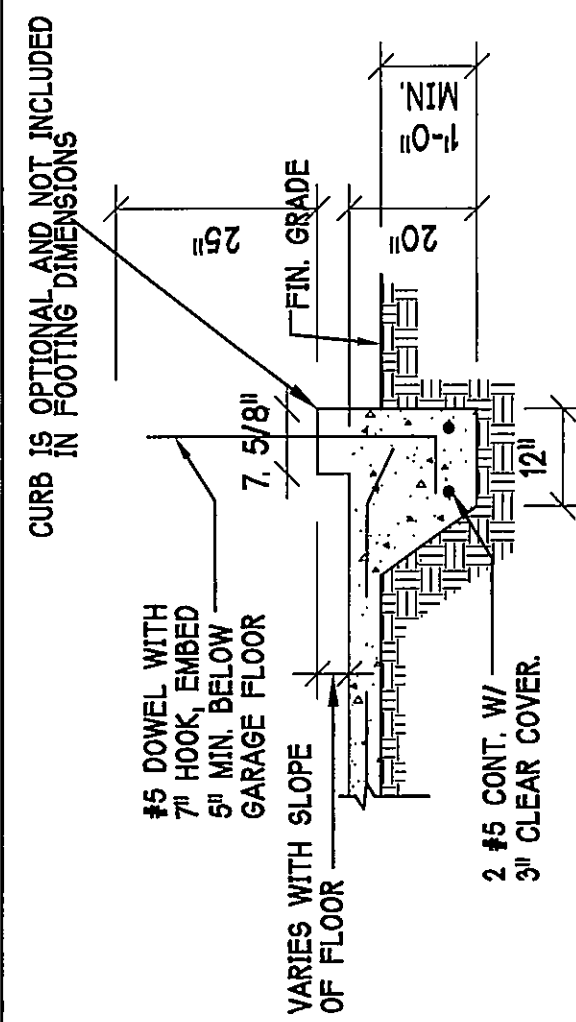


F#3 WITH CURB AT GARAGE

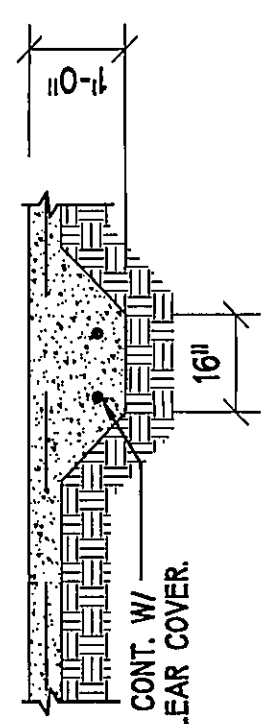


F#5 FOOTING

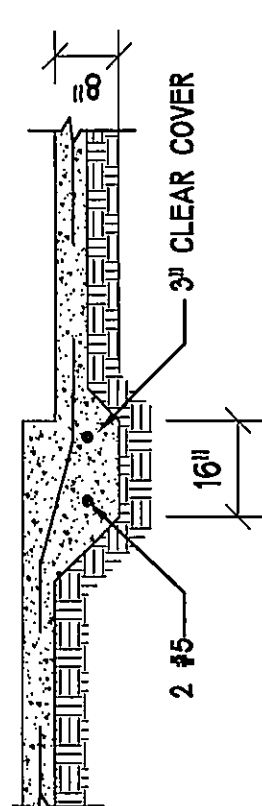

F#6 STEP DOWN

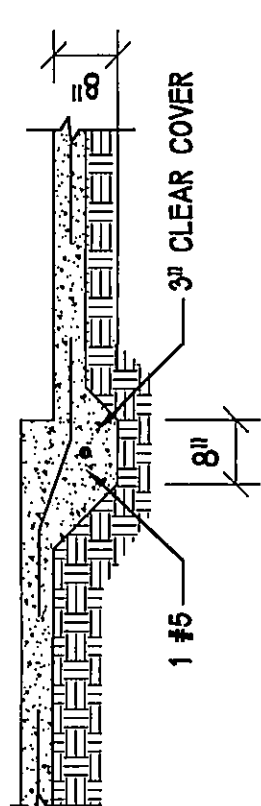

F#6A STEP DOWN

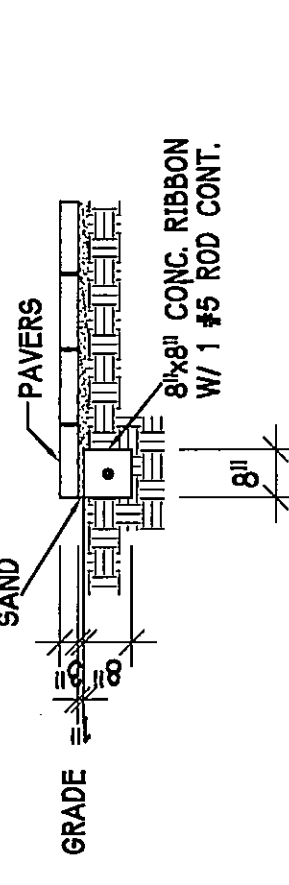

F# PAVERS DETAIL ENTRY/LANAI

WALL FOOTING SCHEDULE				
TYPE	LENGTH	WIDTH	DEPTH	BOTTOM REINFORCING SHAPE
F1	CONT.	1'-4"	0'-8"	2-#5
F2	CONT.	1'-8"	0'-10"	2-#5
F3	CONT.	1'-8"	1'-8"	2-#5
F4	CONT.	1'-4"	1'-0"	2-#5
F5	CONT.	1'-4"	1'-0"	2-#5
F6	CONT.	1'-4"	1'-0"	2-#5
TE	CONT.	8"	8"	1-#5

ADD CURB TO GARAGE, SEE DETAIL

STRUCTURAL SYSTEMS OF NORTH FLORIDA
BERNARD BERGEMAN P.E.
JUL 23 2014
PE #58552
This signature and seal is for work performed by the Structural Engineer of Record (SE) after the SE has reviewed and approved the design. The work was performed by the SE in accordance with the Florida Building Code, Chapter 6, Part 1, Section 601.1, which requires the SE to be a duly licensed Professional Engineer in the State of Florida.

LOT: 15
BLOCK : 7007
SUBDIV: CELEBRATION CAPE
ADDRESS: 211 DESTINY CIRCLE
G.C.D. JOB #: 7977

MODEL: UNIT 1983
RESIDENCE FOR: SPEC

DATE: 7-22-14
DRAWN BY: GCH
CHECKED BY: JWC
REVISED:
PLAN: FOUNDATION
SCALE: 1/4"=1'-0"
SHEET# A-2

D-R-HORTON, INC.
America's Builder

Gulf Coast Drafting & Design
Phone (239) 540-1822
Fax (239) 540-7759

INTERIOR DOOR SCHEDULE		
MARK	DOOR WIDTH	NOTES
1	3'-0"	P.K. = POCKET DOOR
2	2'-8"	B.F. = BI-FOLD DOOR
3	2'-6"	B.P. = BI-PASS DOOR
4	2'-4"	L.V. = LOUVERED DOOR
5	2'-0"	
6	1'-8"	
7	1'-6"	

D R HORTON Wind Pressures Per ASCE7-10, 160 MPH Exposure B, AND CONVERTED TO ALLOWABLE STRESS DESIGN PRESSURES USING 0.6W LOAD FACTOR. Vane=124 MPH					
MARK	SIZE	PRODUCT	DOOR	WIND	WIND-BORNE
CODE	DESCRIPTION	WIDTH	HEIGHT	ZONE	DEBRIS PROTECTION
1	OVERHEAD GARAGE DOOR	182	84	445	123.3/260
2	3080 DR. DISTINCTION	36	96	5	127.7/370
3	ENTRY DR.	12	96	4	127.7/370
4	OVERHEAD GARAGE DOOR	96	84	445	123.3/260

WIND PRESSURES PER ASCE7-10, 160 MPH EXPOSURE B, AND CONVERTED
TO ALLOWABLE STRESS DESIGN PRESSURES USING 0.6W LOAD FACTOR.
Vane=124 MPH

D R HORTON Wind Pressures Per ASCE7-10, 160 MPH Exposure B, AND CONVERTED TO ALLOWABLE STRESS DESIGN PRESSURES USING 0.6W LOAD FACTOR. Vane=124 MPH					
MARK	SIZE	PRODUCT	DOOR	WIND	WIND-BORNE
CODE	DESCRIPTION	WIDTH	HEIGHT	ZONE	DEBRIS PROTECTION
1	OVERHEAD GARAGE DOOR	182	84	445	123.3/260
2	3080 DR. DISTINCTION	36	96	5	127.7/370
3	ENTRY DR.	12	96	4	127.7/370
4	OVERHEAD GARAGE DOOR	96	84	445	123.3/260



OPT. IMPACT GLASS MAY BE INSTALLED
IN LIEU OF SHUTTERS VERIFY W/ CONTRACT

Gulf Coast Drafting
& Design
Phone (239) 540-1822
Fax (239) 540-7759

STRUCTURAL
ENGINEERING
JUL 23 2014
FL PE #38552
G.C.D. JOB #: 7977

MODEL: UNIT 1983
RESIDENCE FOR: SPEC
ADDRESS: 211 DESTINY CIRCLE
SUBDIV: CELEBRATION CAPE
LOT: 15 BLOCK: 7007

REVIEWED
DATE: 12/14
G.C.D. JOB #: 7977

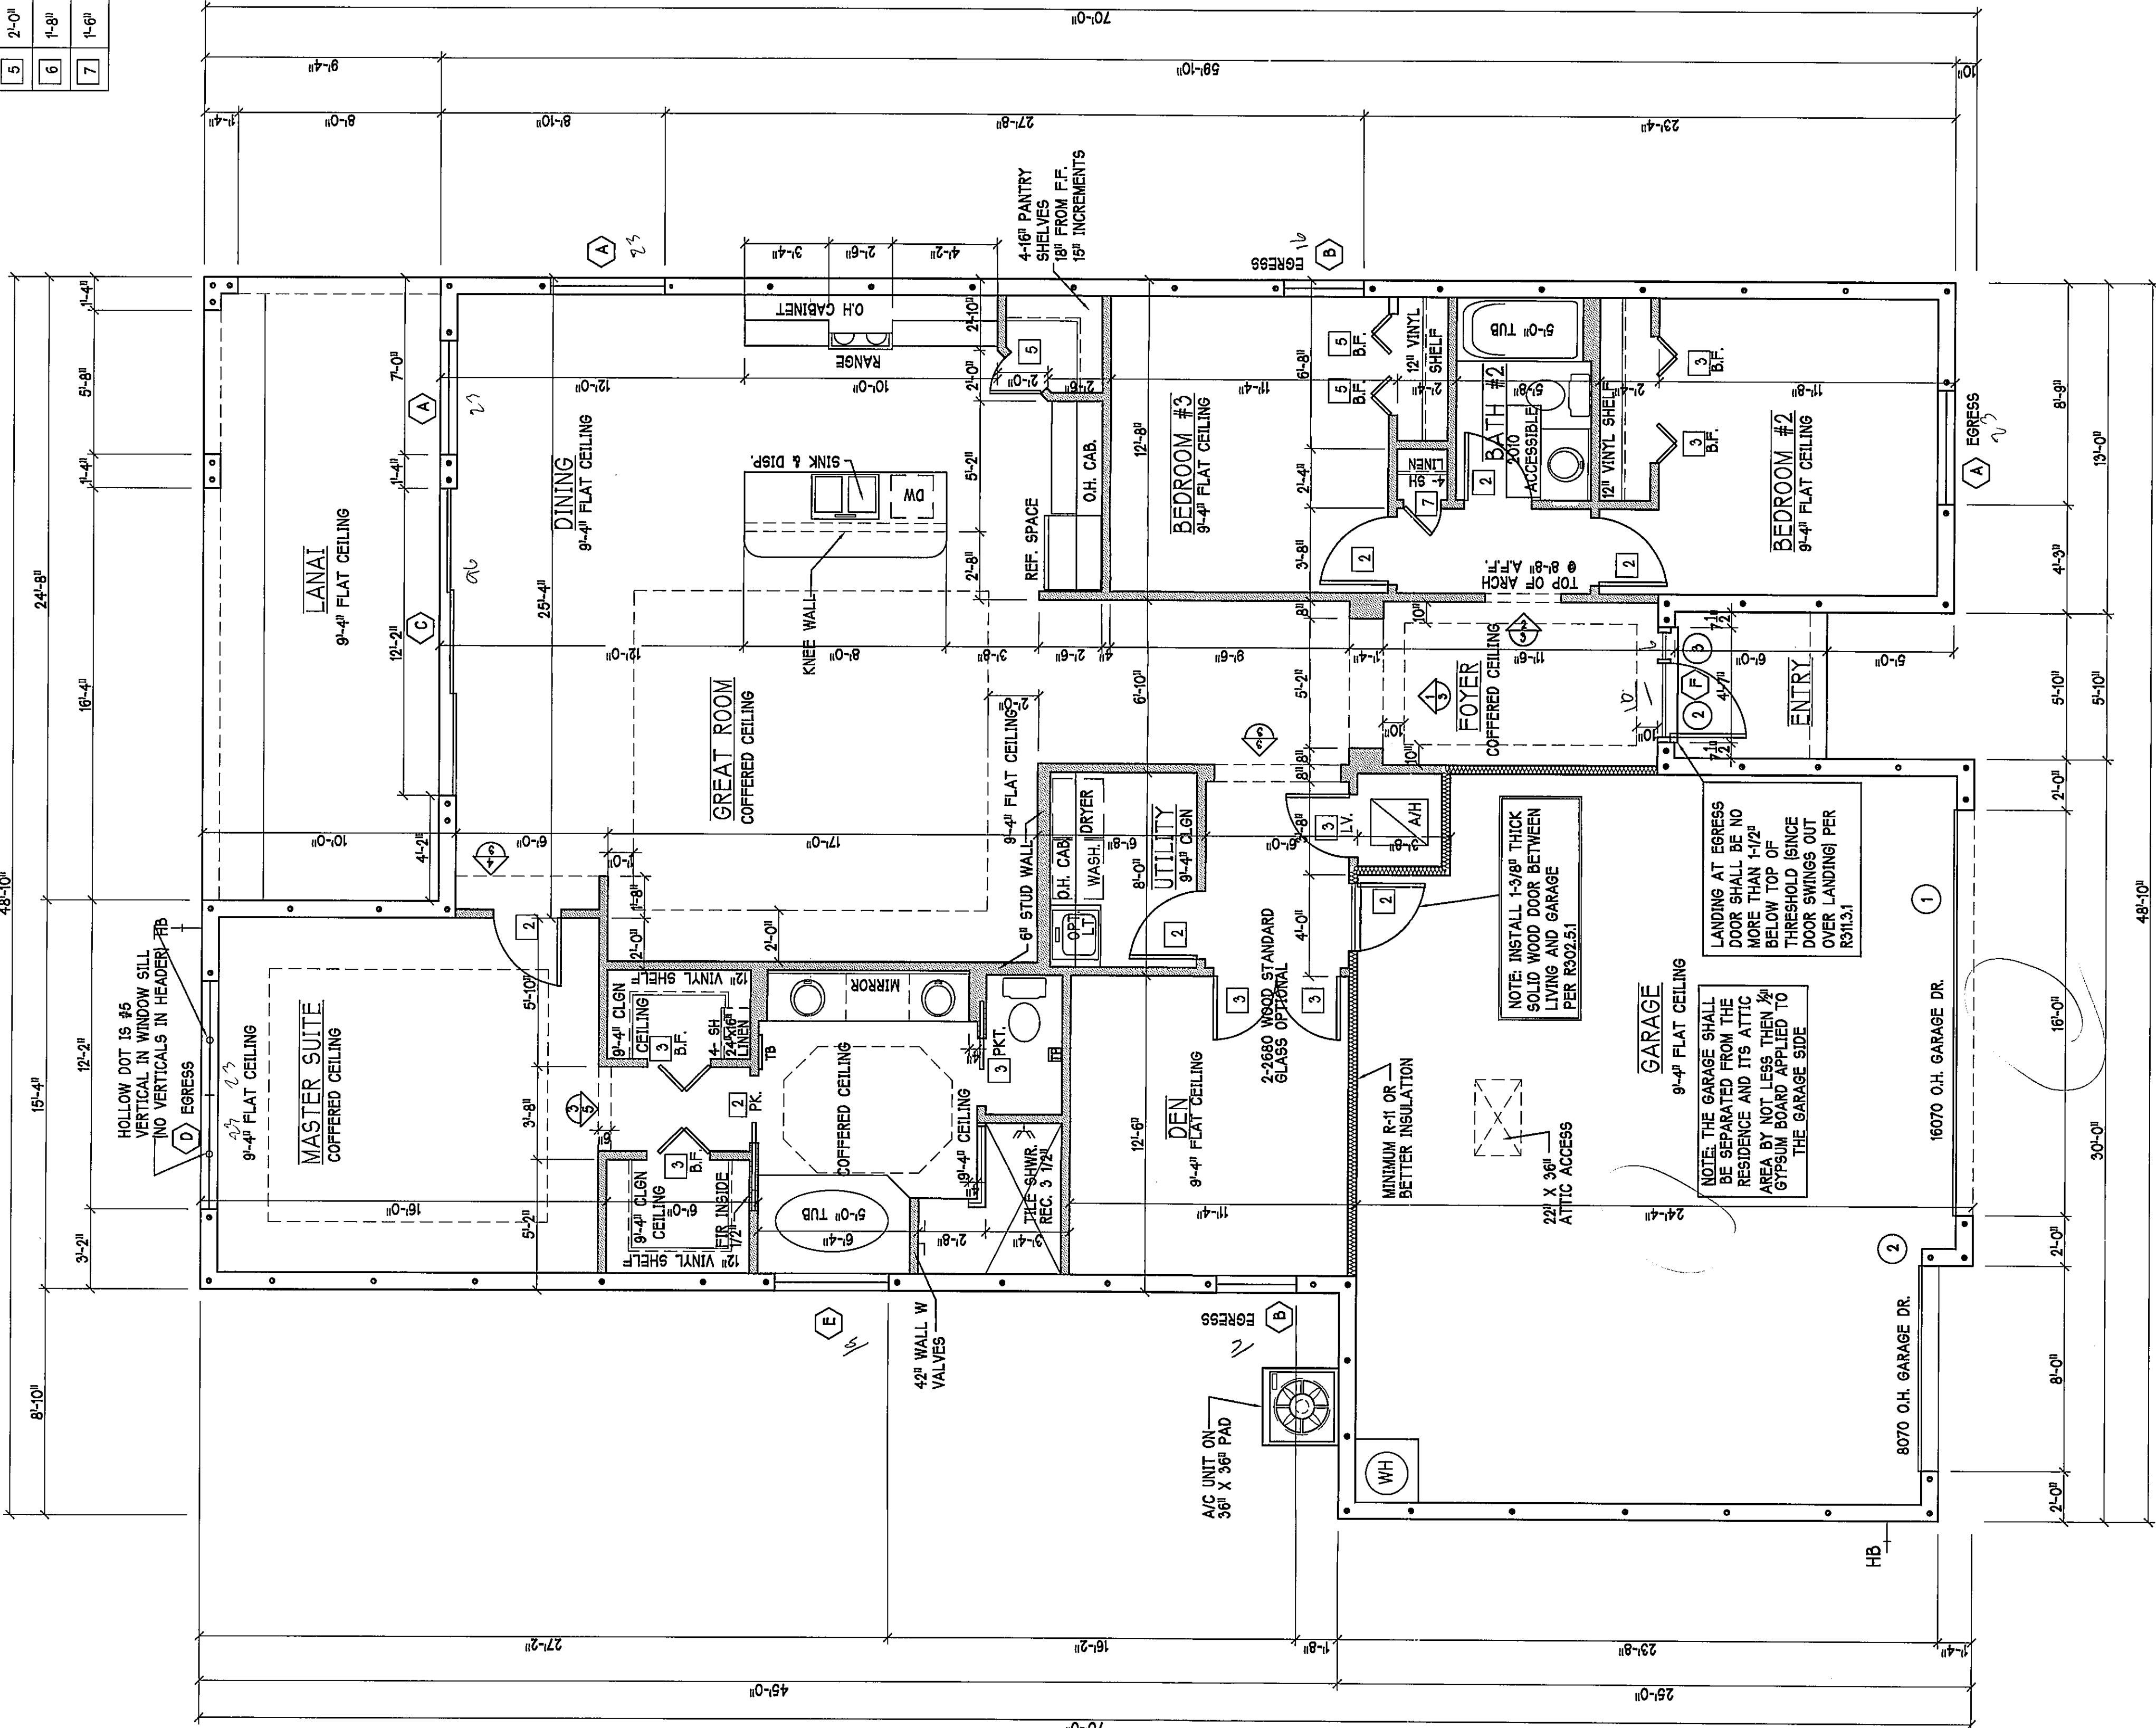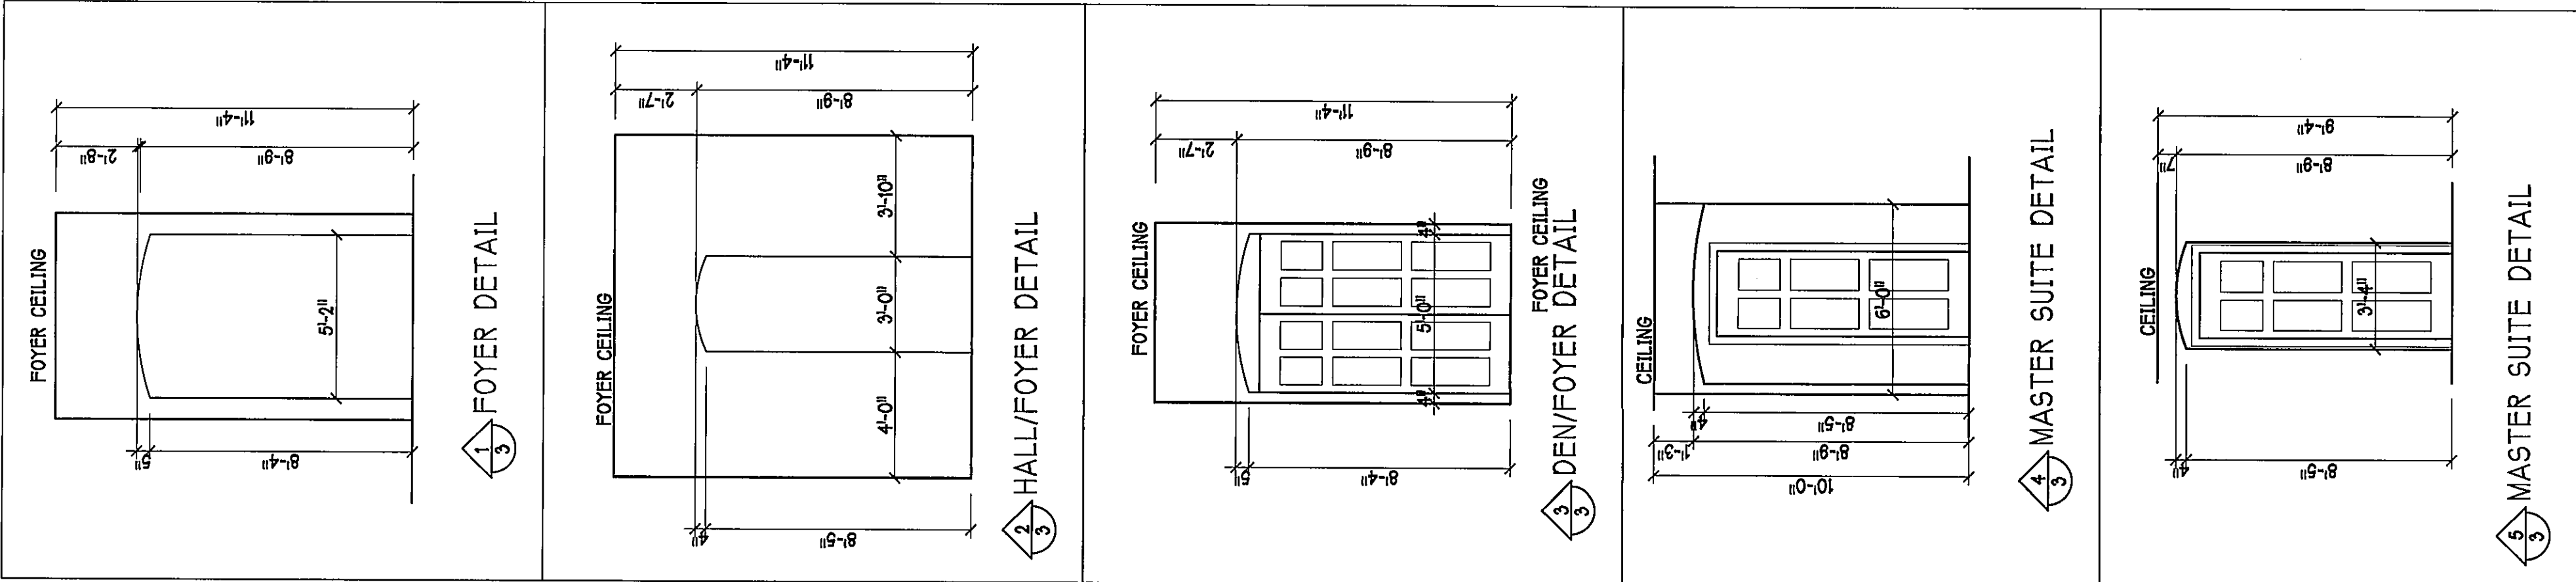

1st FLOOR PLAN: SCALE: 1/4" = 1'-0"

SQUARE FOOTAGE	
FLOOR LIVING AREA	1885
GARAGE AREA	716
ENTRY AREA	35
LANAI AREA	230
TOTAL AREA	2862

VINYL SHELF NOTES:
1) ALL CLOSET SHELVES TO BE 1/2"
2) ALL PANTRY & LINEN TO BE 1/2"
SHELVES 1/2" O.F.F. WITH 1/2" INCREMENT.


DOOR HEADERS
6'-0" BIFOLD HEADER HEIGHT 82" A.F.F.
6'-0" SWING HEADER HEIGHT 82 1/2" A.F.F.
8'-0" SWING HEADER HEIGHT 98 1/2" A.F.F.

BATHROOM NOTES
ALL TUB DECKS @ 2" AFF.
ALL BLOCKING TO BE PT IN SHOWERS

CABINET BACKING
KITCHEN UPPER TOP @ 54" & 80" BASE TOP 86 1/2"
MASTER BATH UPPER
GUEST BATH UPPER
LAUNDRY RM. UPPER TOP @ 86 1/2" BASE
ALL TUB DECKS @ 2" AFF.

PLAN NOTES:
1) KITCHEN KNEE WALL 42 1/2" TO TOP USING 2x4 TOP PLATE.
2) MEDICINE CABINETS OPENING 14x18 TOP OF OPENING @ 72" / 5" OFF WALL.
3) JOB MUST BE BROOM SWEEP EVERYDAY.
4) VERIFY ROUGH OPENING DIMENSIONS FOR ALL WINDOWS AND DOORS.
5) PROVIDE DEAD WOOD IN ATTIC FOR OVERHEAD GARAGE DOOR HARDWARE.
6) INSTALL SMOOTH WALLS IN KITCHEN AND ALL BATHROOM AREAS.
7) WHERE DRYWALL CEILING IS APPLIED TO TRUSSES AT 24" O.C. USE 5/8" DRYWALL OR 1/2" SAG RESISTANT PER SEC. 702.3.3.

PROVIDE SAFETY GLAZING WITHIN 24" FROM EXIT DOOR.
[PER FLORIDA BUILDING CODE-R308.3.1]
NOTE: PROVIDE SAFETY GLAZING AT BATH/SHR. SHALL COMPLY WITH R 308.3.1
***** NOTE: *****
STUB OUT FOR GAS @ OUTDOOR KITCHEN. MUST HAVE GAS PIPING AND VENT. VERIFY WITH CONTRACTOR SUBMITTER. A SEPARATE PERMIT IS REQUIRED FOR GAS PIPING.

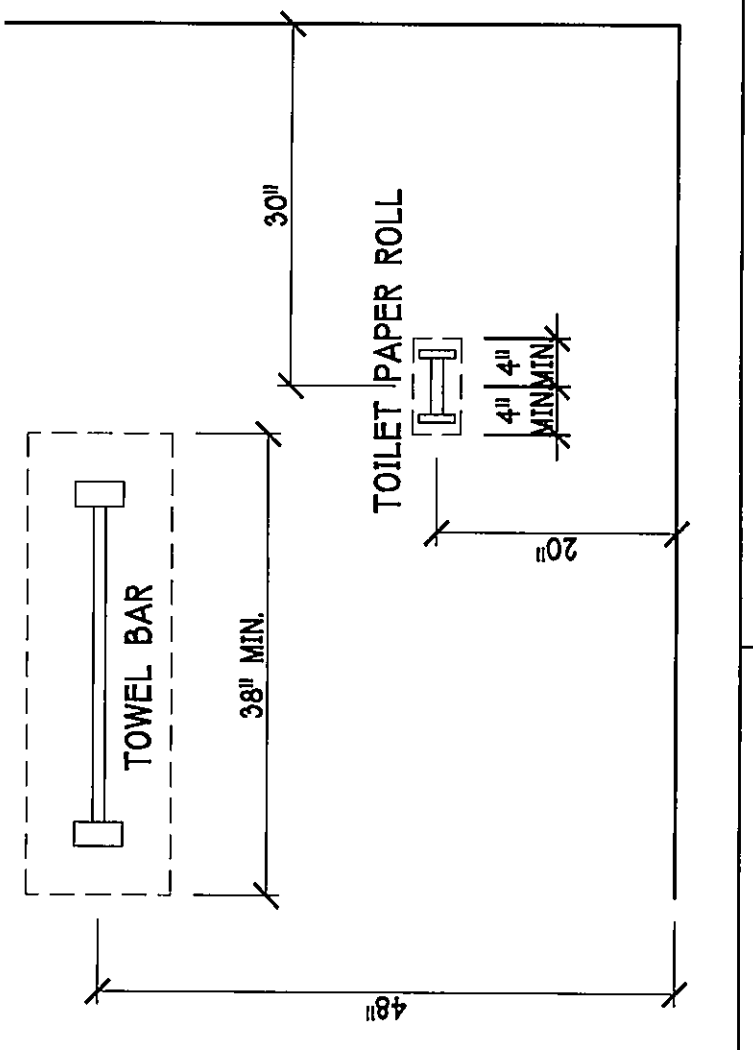

BATHROOM NOTES
TOWEL BAR
TUB
TOILET PAPER
ALL TUB DECKS @ 2" AFF.
ALL BLOCKING TO BE PT IN SHOWERS

ATTIC VENTILATION			
VENTILATION REQUIREMENT with energy calculations		WITHOUT OFF RIDGE VENTS	WITH OFF RIDGE VENTS
ATTIC AREA [FBC R806]	VENTILATION REQUIRED [ATTIC AREA / 1450]	VENTILATION REQUIRED [ATTIC AREA / 2000 INSTALL PER FBC R8062 MINIMUM AREA REQUIREMENTS]	
mark	square footage	soffit vents	total ventilation off ridge vents soffit vents
(1)	2062 SQ. FT.	19.8 SQ. FT.	9.9 SQ. FT. 4.95 SQ. FT. 4.95 SQ. FT. 9.9 SQ. FT.
		ATTIC VENTILATION CALCULATION: attic sq. ft. / 650 = vented sq. ft.	ATTIC VENTILATION CALCULATION: attic sq. ft. / 300 = vented sq. ft.
145 SQ. FT. FREE AREA		1 SQ. FT. FREE AREA	38 SQ. FT. FREE AREA
OFF RIDGE EXHAUST VENT SIZES [AREA NET FREE SPACE FEET]			
SCALE: 1/4\"=1'-0\"			

BEARING HEIGHT



= INTERIOR BEARING @ 9-4° A.F.F.

= BEARING @ 9-4° A.F.F.

= BEARING @ 14-0° A.F.F.



REVIEWED
 Final Design
 DATE 02/01/00
 BY *[Signature]*
 CHECKED *[Signature]*
 DATE 02/01/00
 ALL CONSTRUCTION SHALL BE IN ACCORDANCE WITH THE LATEST EDITION OF THE AISC STEEL CONSTRUCTION MANUAL. THE DESIGN OF THIS CONNECTION SHALL BE IN ACCORDANCE WITH THE LATEST EDITION OF THE AISC STEEL CONSTRUCTION MANUAL. THE DESIGN OF THIS CONNECTION SHALL BE IN ACCORDANCE WITH THE LATEST EDITION OF THE AISC STEEL CONSTRUCTION MANUAL.

HOOK #5 BAR INTO TOP OF BOND BEAM
 WALL ABOVE WITH BOND BEAM AT TOP
 #5 VERTICAL, ABOVE LINTEL ONLY, WHERE NOTED ON PLAN
 '1B' DENOTES '1#5 BOTTOM WITH 7\" HOOK EACH END EXTENDING 24\" BEYOND OPENING.
 '0B' DENOTES "NO REBAR"
 8" PRECAST LINTEL
 8ES-1B
 8ES-0B
 16" GRouted
 16" GRouted
 1" #5 TOP
 1" #5 BOTTOM
 8ET6-1B/1I

PRECAST LINTEL SCHEDULE

AT SWING DOORS, USE 2" RECESS STYLE LINTEL IF REQUIRED FOR ROUGH OPENING.

PLAN NOTES:
 1) ROOF TRUSS BEARING ELEVATION VARIES, SEE LEGEND.
 2) ROOF TRUSSES SHALL BE WOOD TRUSSES DESIGNED BY A DELEGATED TRUSS ENGINEER PER DESIGN CRITERIA ON SHEET S-1.

5) 6F8-18 etc.,	denotes PRECAST Lintel ABOVE DOOR/WINDOW OPENING PER SCHEDULE THIS
6) AT TRUSS BEARING, PROVIDE 8x8 MASONRY BOND BEAM W/ #5 CONTINUOUS, SEE DETAIL 2/H/	

TRUSS STRAPPING TO MASONRY			
MAX TRUSS UPLIFT @ 24" (LBS)	CONNECTOR	FASTENER	
1450	(1)METHA16 TO 40	9-10x41 $\frac{1}{2}$ "	EMBED 4"
1810	(1)METHA16 TO 40	10-10x41 $\frac{1}{2}$ "	EMBED 4"
2235	(1)METHA16 TO 40	12-10x41 $\frac{1}{2}$ "	EMBED 4"
1985	(1)PLY	12-10x41 $\frac{1}{2}$ "	EMBED 4"
1900 (2 PLY)	(2)METHA12 TO 40	14-18x4	EMBED 4"
2500 (2 PLY)	(2)METHA12 TO 40	14-18x4	EMBED 4"
2500 (2 PLY)	(2)METHA12 TO 22	14-18x4	EMBED 4"

SEE NOTES

PROVIDE A STRAP FROM THE ABOVE LIST AT EACH ROOF TRUSS BEARING BASED ON THE TRUSS UPLIFT VALUES IN THE SIGNED AND SEALED TRUSS PACKAGE AND SUITABLE FOR THE GEOMETRY. ALL CONNECTED STRAP ON E OF WALL

2) CONNECTORS ARE SIMPSON STRONG IRY. ALL CONNECTORS SHALL BE INSTALLED IN STRICT ACCORDANCE WITH SIMPSON PRINTED INSTRUCTIONS. SUBSTITUTIONS MUST BE APPROVED IN WRITING BY THE ENGINEER OF RECORD.

3) WHERE EMBEDDED STRAPS ARE MISSING, OR MIS-LOCATED, INSTALL RETROFIT STRAP PER 10/5-1.

DESIGN IN ACCORDANCE WITH THE FOLLOWING:

NOTES:

1) PROVIDE A STRAP FROM THE ABOVE LIST AT EACH ROOF TRUSS BEARING P
BASED ON THE TRUSS UPLIFT VALUES IN THE SIGNED AND SEALED TRUSS DESIGN
PACKAGE AND SUITABLE FOR THE GEOMETRY. EMBED STRAP ON C OF WALL.

2) CONNECTORS ARE SUSCEPTIBLE TO ALL CONNECTORS SHALL BE INSTALLED

TO 1430 LB UPLIFT.	1985 (1 PLY)	(2) META12 TO 40	12"-10x1 1/2", EMBED 4"
FOR HIGHER	1900 (2 PLY)	(2) META12 TO 40	14"-16d, EMBED 4"
	2500 (2 PLY)	(2) META12 TO 40	14"-16d, EMBED 4"

STRAP PER 10/S-1.	DESIGN IN ACCORDANCE WITH THE FLORIDA BUILDING CODE
-------------------	---

PLAN NOTES:

- 1) ROOF TRUSS BEARING ELEVATION VARIES, SEE LEGEND.
- 2) ROOF FRAMING SHALL BE WOOD TRUSSES DESIGNED BY A DELEGATED TRUSS ENGINEER PER DESIGNED CRITERIA ON SHEET S-1.
- 3) PROVIDE STRAPPING AT TRUSSES PER NOTES ON THIS SHEET.
- 4) FOR MILING OF ROOF DECK, SEE 1 AND 2 ON S-1.
- 5) **[8F8-1B]** etc., DENOTES PRECAST LUMBER ABOVE DOOR/WINDOW OPENING PER SCHEDULE TWO
- 6) AT TRUSS BEARING, PROVIDE 8X8 MASONRY BLOCK BEAM W/ 1 #5 CONTINUOUS, SEE DETAIL 2/A/1

TRUSS STRAPPING TO MASONRY			
INSTALL	MAX TRUSS UPLIFT @ 24" OC (LBS)	CONNECTOR	FASTENER
ME16A AT	1430	(1)ME16A16 TO 40	9-10x11/2" EMBED 4"
TRUSSES	2335	(1)ME16A16 TO 40	10-10x11/2" EMBED 4"
TO 1450 lb	1985 (1 PLY)	(2)ME16A12 TO 40	12-10x11/2" EMBED 4"
UPLIFT, OTHER	1900 (2 PLY)	(2)ME16A12 TO 40	14-16d, EMBED 4"
UPRITS	2500 (2 PLY)	(2)ME16A12 TO 22	14-16d, EMBED 4"
SEE NOTES	2500 (2 PLY)	(2)ME16A12 TO 22	14-16d, EMBED 4"

NOTES:

- 1) PROVIDE A STRAP FROM THE ABOVE LIST AT EACH ROOF TRUSS BEARING POINT BASED ON THE TRUSS UPLIFT VALUES IN THE SIGNED AND SEALED TRUSS DESIGN PACKAGE AND SUITABLE FOR THE GEOMETRY. EMBED STRAP ON $\frac{1}{2}$ " OF WALL.
- 2) CONNECTORS ARE SIMPSON STRONG TIE ALL CONNECTORS SHALL BE INSTALLED IN ACCORDANCE WITH THE MANUFACTURER'S SUBSTITUTIONS.
- 3) ALL CHANGES MUST BE APPROVED IN WRITING BY THE ENGINEER OF RECORD.
- 3) WHERE EMBEDDED STRAPS ARE MISSING, OR MIS-LOCATED, INSTALL RETROFIT STRAP PER 10/5-1.

STRAP PER 10/S-1.	DESIGN IN ACCORDANCE WITH THE FLORIDA BUILDING CODE
-------------------	---

DATE: 7-22-14

DRAWN BY: GCH

CHECKED BY: JWC

REVISED:

PLAN: ELECTRICAL

SCALE: 1/4" = 1'-0"

SHEET#

A-5

Gulf Coast Drafting & Design


Phone (239) 540-1822

Fax (239) 540-7759


D-R-HORTON

USA

America's Builder

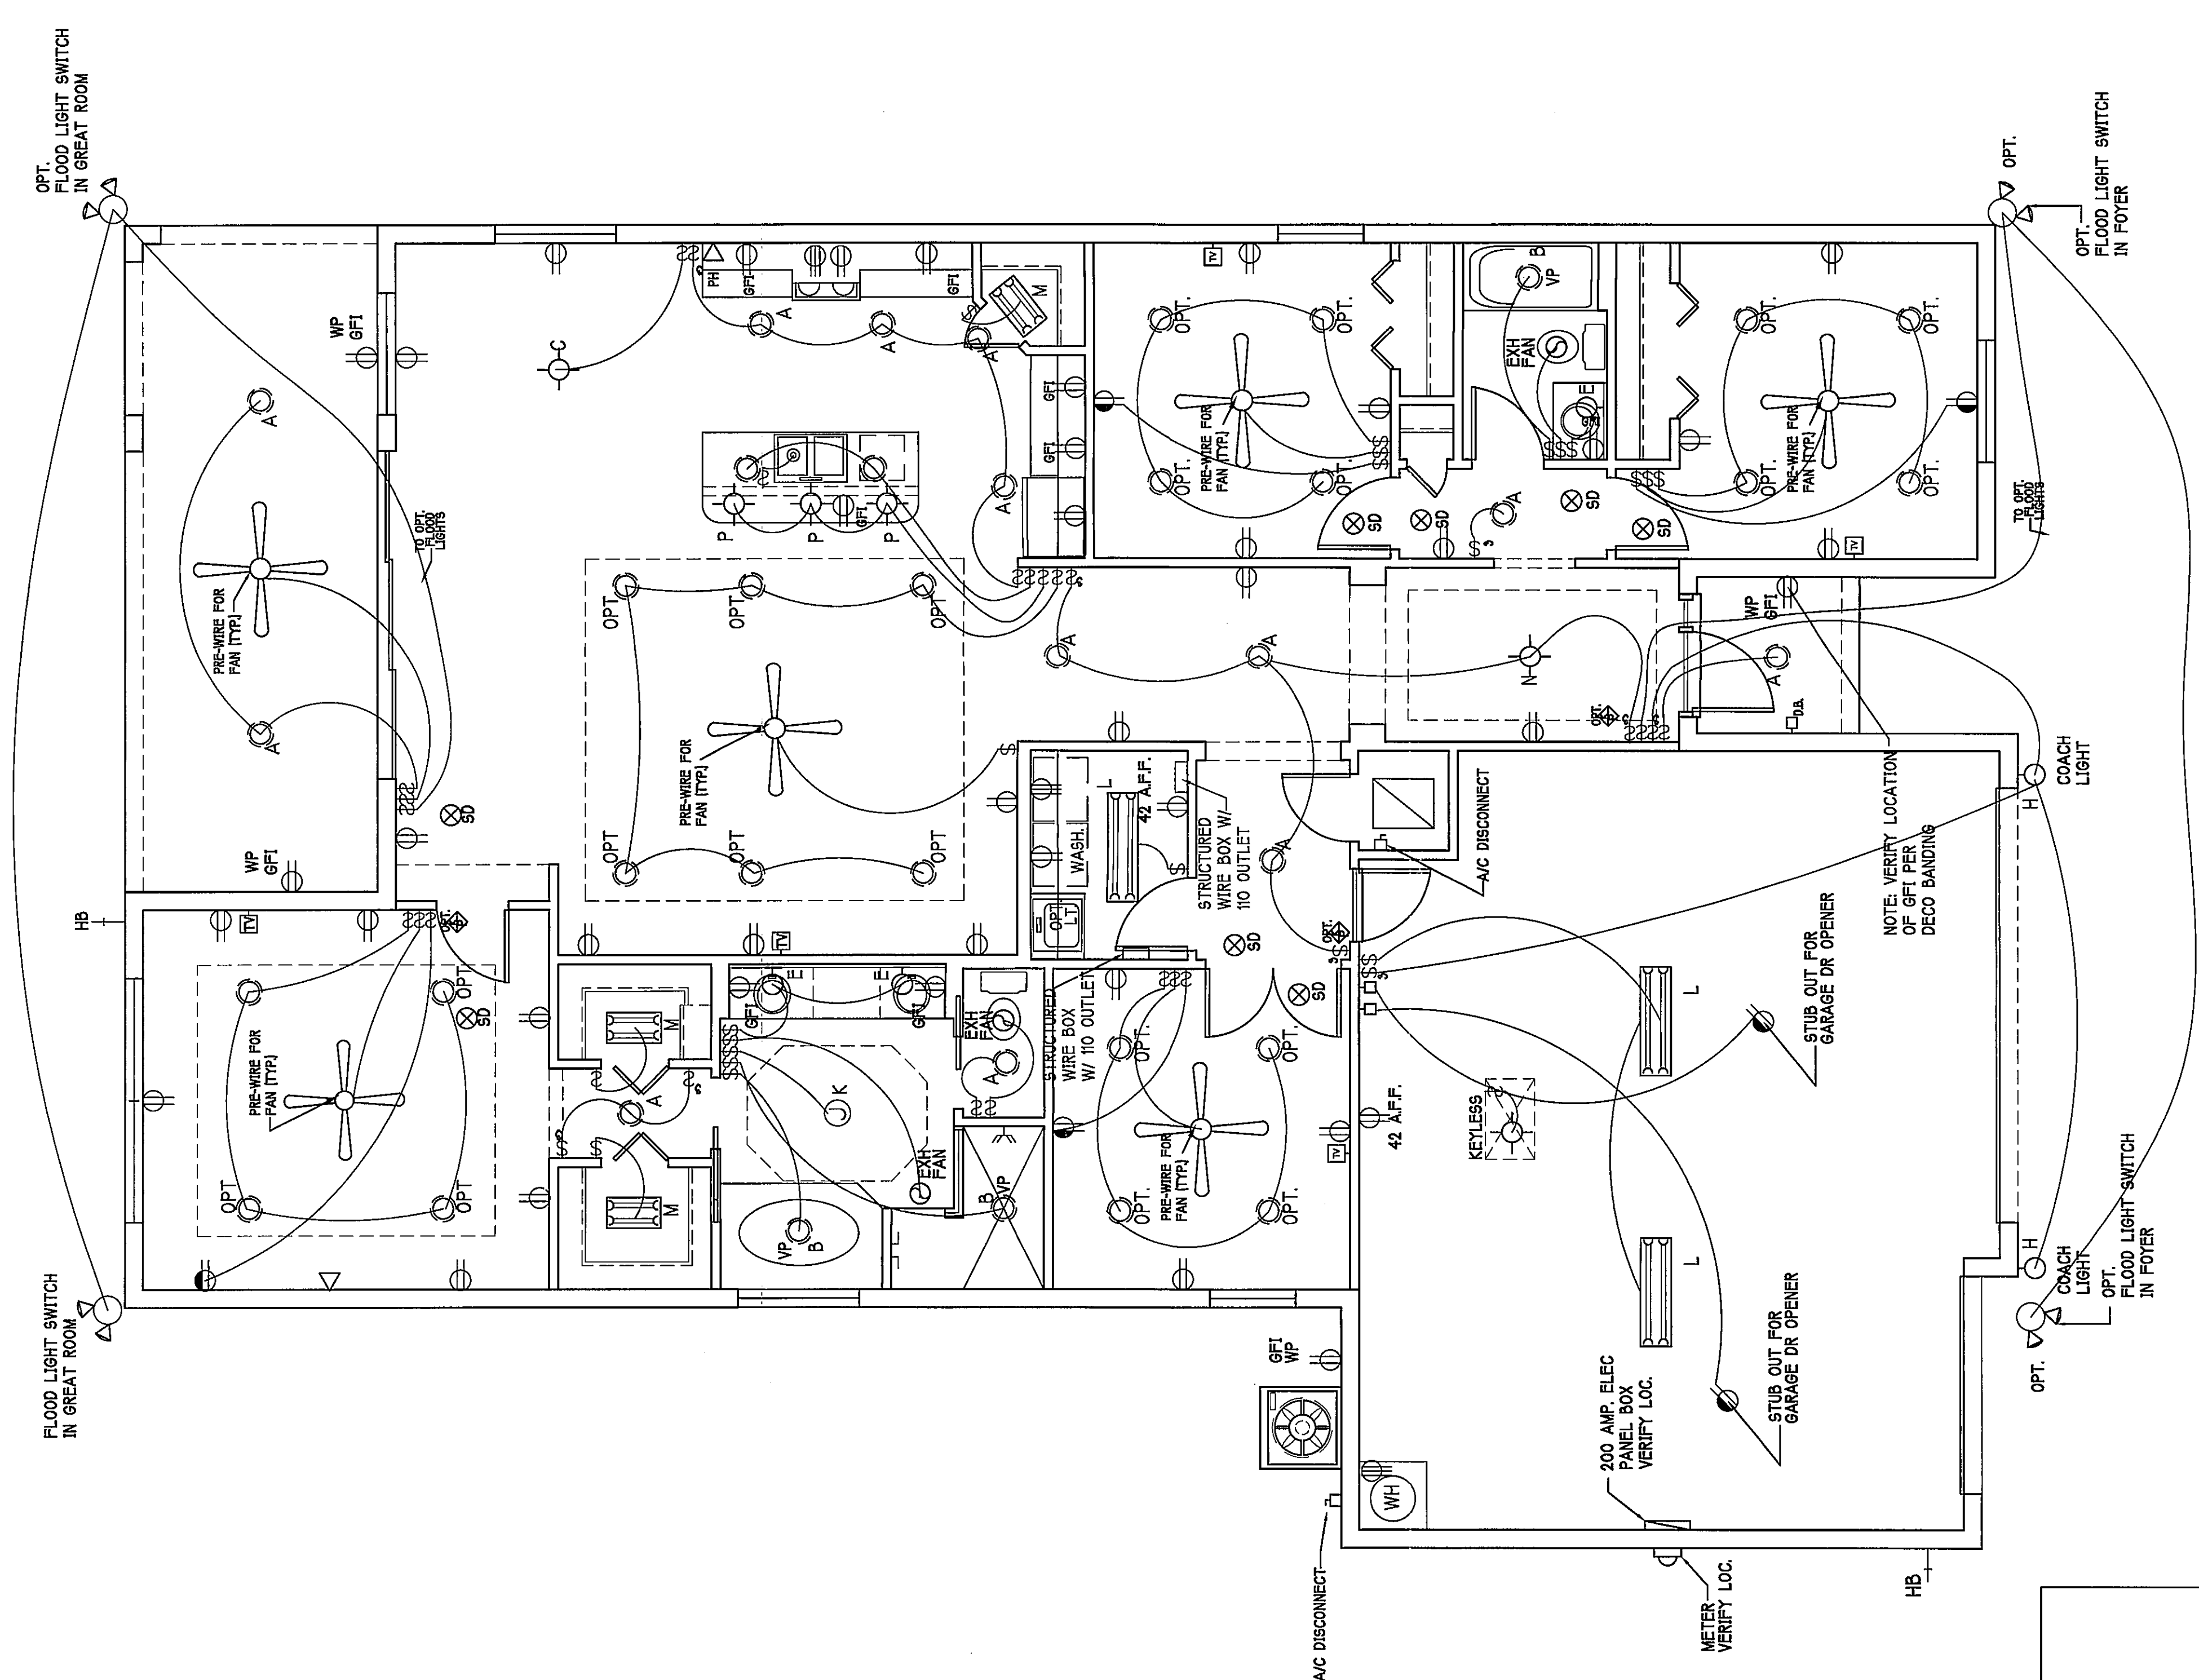

ELECTRICAL PLAN: SCALE: 1/4" = 1'-0"

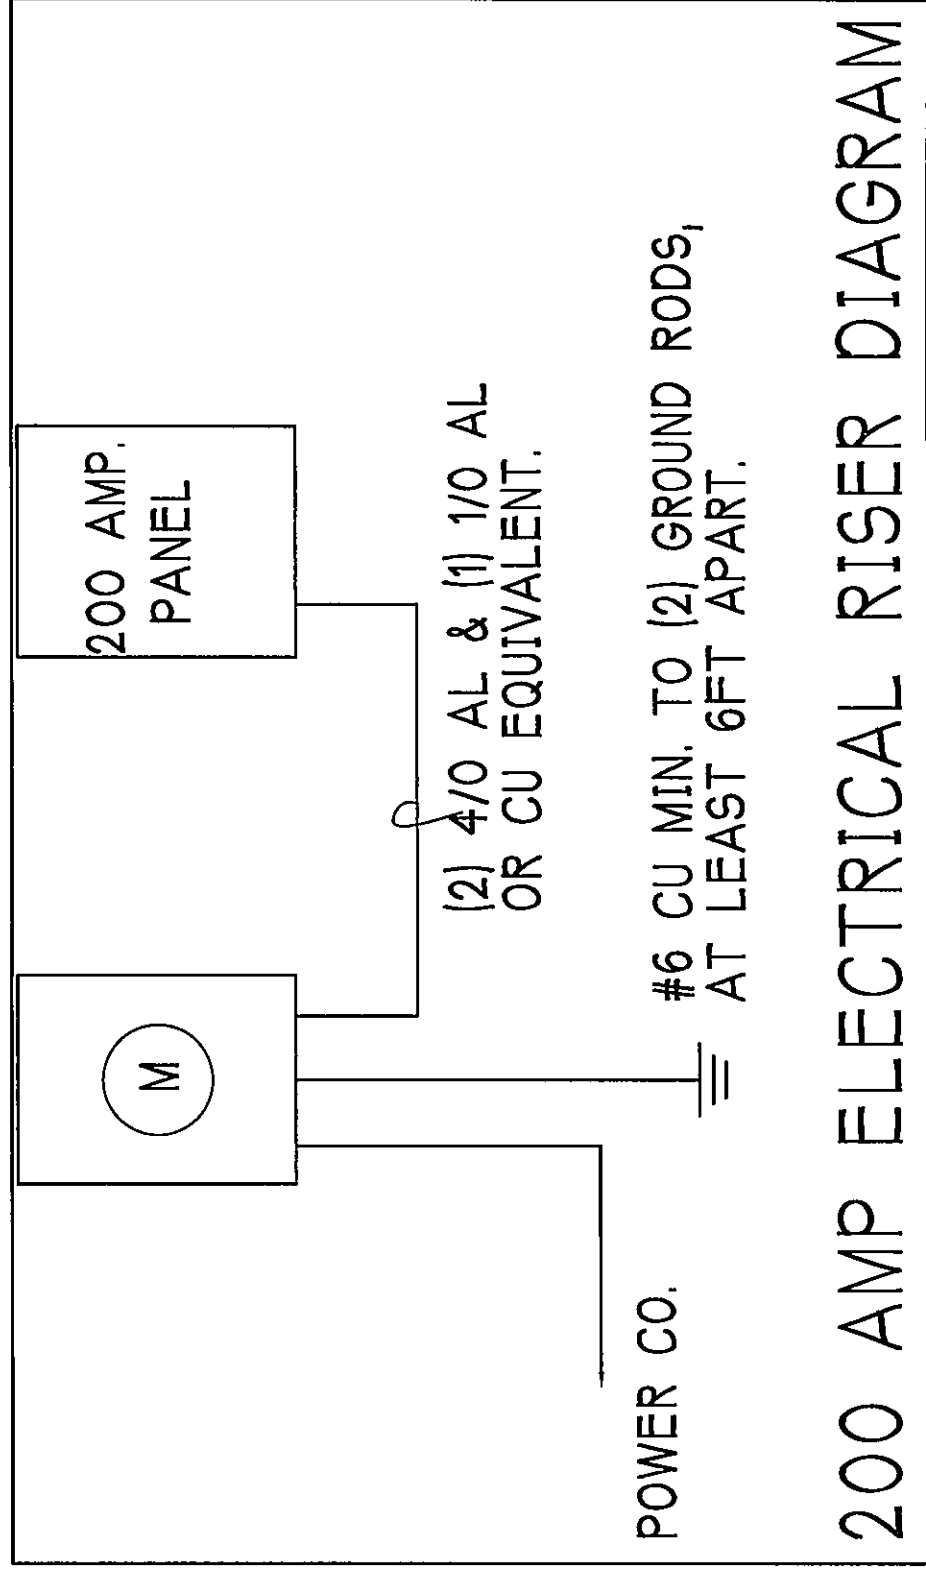

OPTIONAL ELECTRICAL PLAN 1983

200 Amp Service		PRODUCT		PRODUCT #
TAG	QUANTITY			
A	(37)	Recessed Cans		P4070-09
B	(3)	Vapors		P3410-30
C	(1)	Pendant/Nook		P3268-09
D	(X)	10" Mushroom		P3269-09
E	(3)	24" Avalon 3 LT		NOT USED
F	(X)	36" Avalon 4 LT		P5815-30
G	(X)	NOT USED		P5683-30
H	(2)	Coach Lights		P7186-30
J	(X)	Coach Lights		P7183-30
K	(2)	J BOX		P4068-09
L	(2)	4" Fluorescent		P3773-09
M	(3)	2' Fluorescent		P-5068-09
N	(1)	5lt Chandelier		
O	(1)	3 LT Avalon		
P	(3)	Pendant Light		

Electrical Notes:
Arc-Fault circuit-Interruption & Tamper-Resistant receptacles shall be installed in dwelling units per NEC 210.2 & 400.1
All electrical equipment to be set at or above base flood elevation
All outlets in wet areas and all exterior outlets to be GFI's
Install Phone & TV per contract. . .
INSTALL ALL ELECTRICAL PER NEC 2008


ELECTRICAL LEGEND	
	ELECTRICAL METER
	ELECTRICAL PANEL
	120 V JUNCTION BOX
	SINGLE RECEPTACLE OUTLET
	220 V RECEPTACLE OUTLET
	4-PLEX RECEPTACLE OUTLET
	DUPLEX RECEPTACLE OUTLET
	1/2 SWITCHED DUPLEX OUTLET
	DUPLEX RECEPTACLE • ELEV. AFF.
	TIMER SWITCH
	GFI SWITCH
	DIMMER SWITCH
	3 WAY SWITCH
	SINGLE POLE SWITCH
	120/240 SMOKE DETECTOR
	50 AMP BREAKER
	40 AMP BREAKER
	30 AMP BREAKER
	20 AMP BREAKER
	15 AMP BREAKER
	10 AMP BREAKER
	5 AMP BREAKER
	TELEPHONE OUTLET
	TELEVISION RECEPTION OUTLET
	SURFACE MOUNTED CEILING LIGHT
	RECESSED LIGHT
	WALL MTD BRACKET LIGHT
	EXHAUST FAN
	A/C DISCONNECT
	PUSH BUTTON
	DB= DOOR BELL

DATE:	7-22-14
DRAWN BY:	GCH
CHECKED BY:	JWC
REVISED:	
PLAN:	BANDING DETAILS
SCALE:	N.T.S.
SHEET#	A-7

MODEL:	UNIT 1983	RESIDENCE FOR: SPEC
LOT: 15		
BLOCK : 7007		
SUBDIV: CELEBRATION CAPE		
ADDRESS: 211 DESTINY CIRCLE	G.C.D. JOB #: 7977	

**Gulf Coast Drafting
& Design**
Phone (239) 540-1822
Fax (239) 540-7759

D. R. HORTON PHI NYSE *America's Builder*

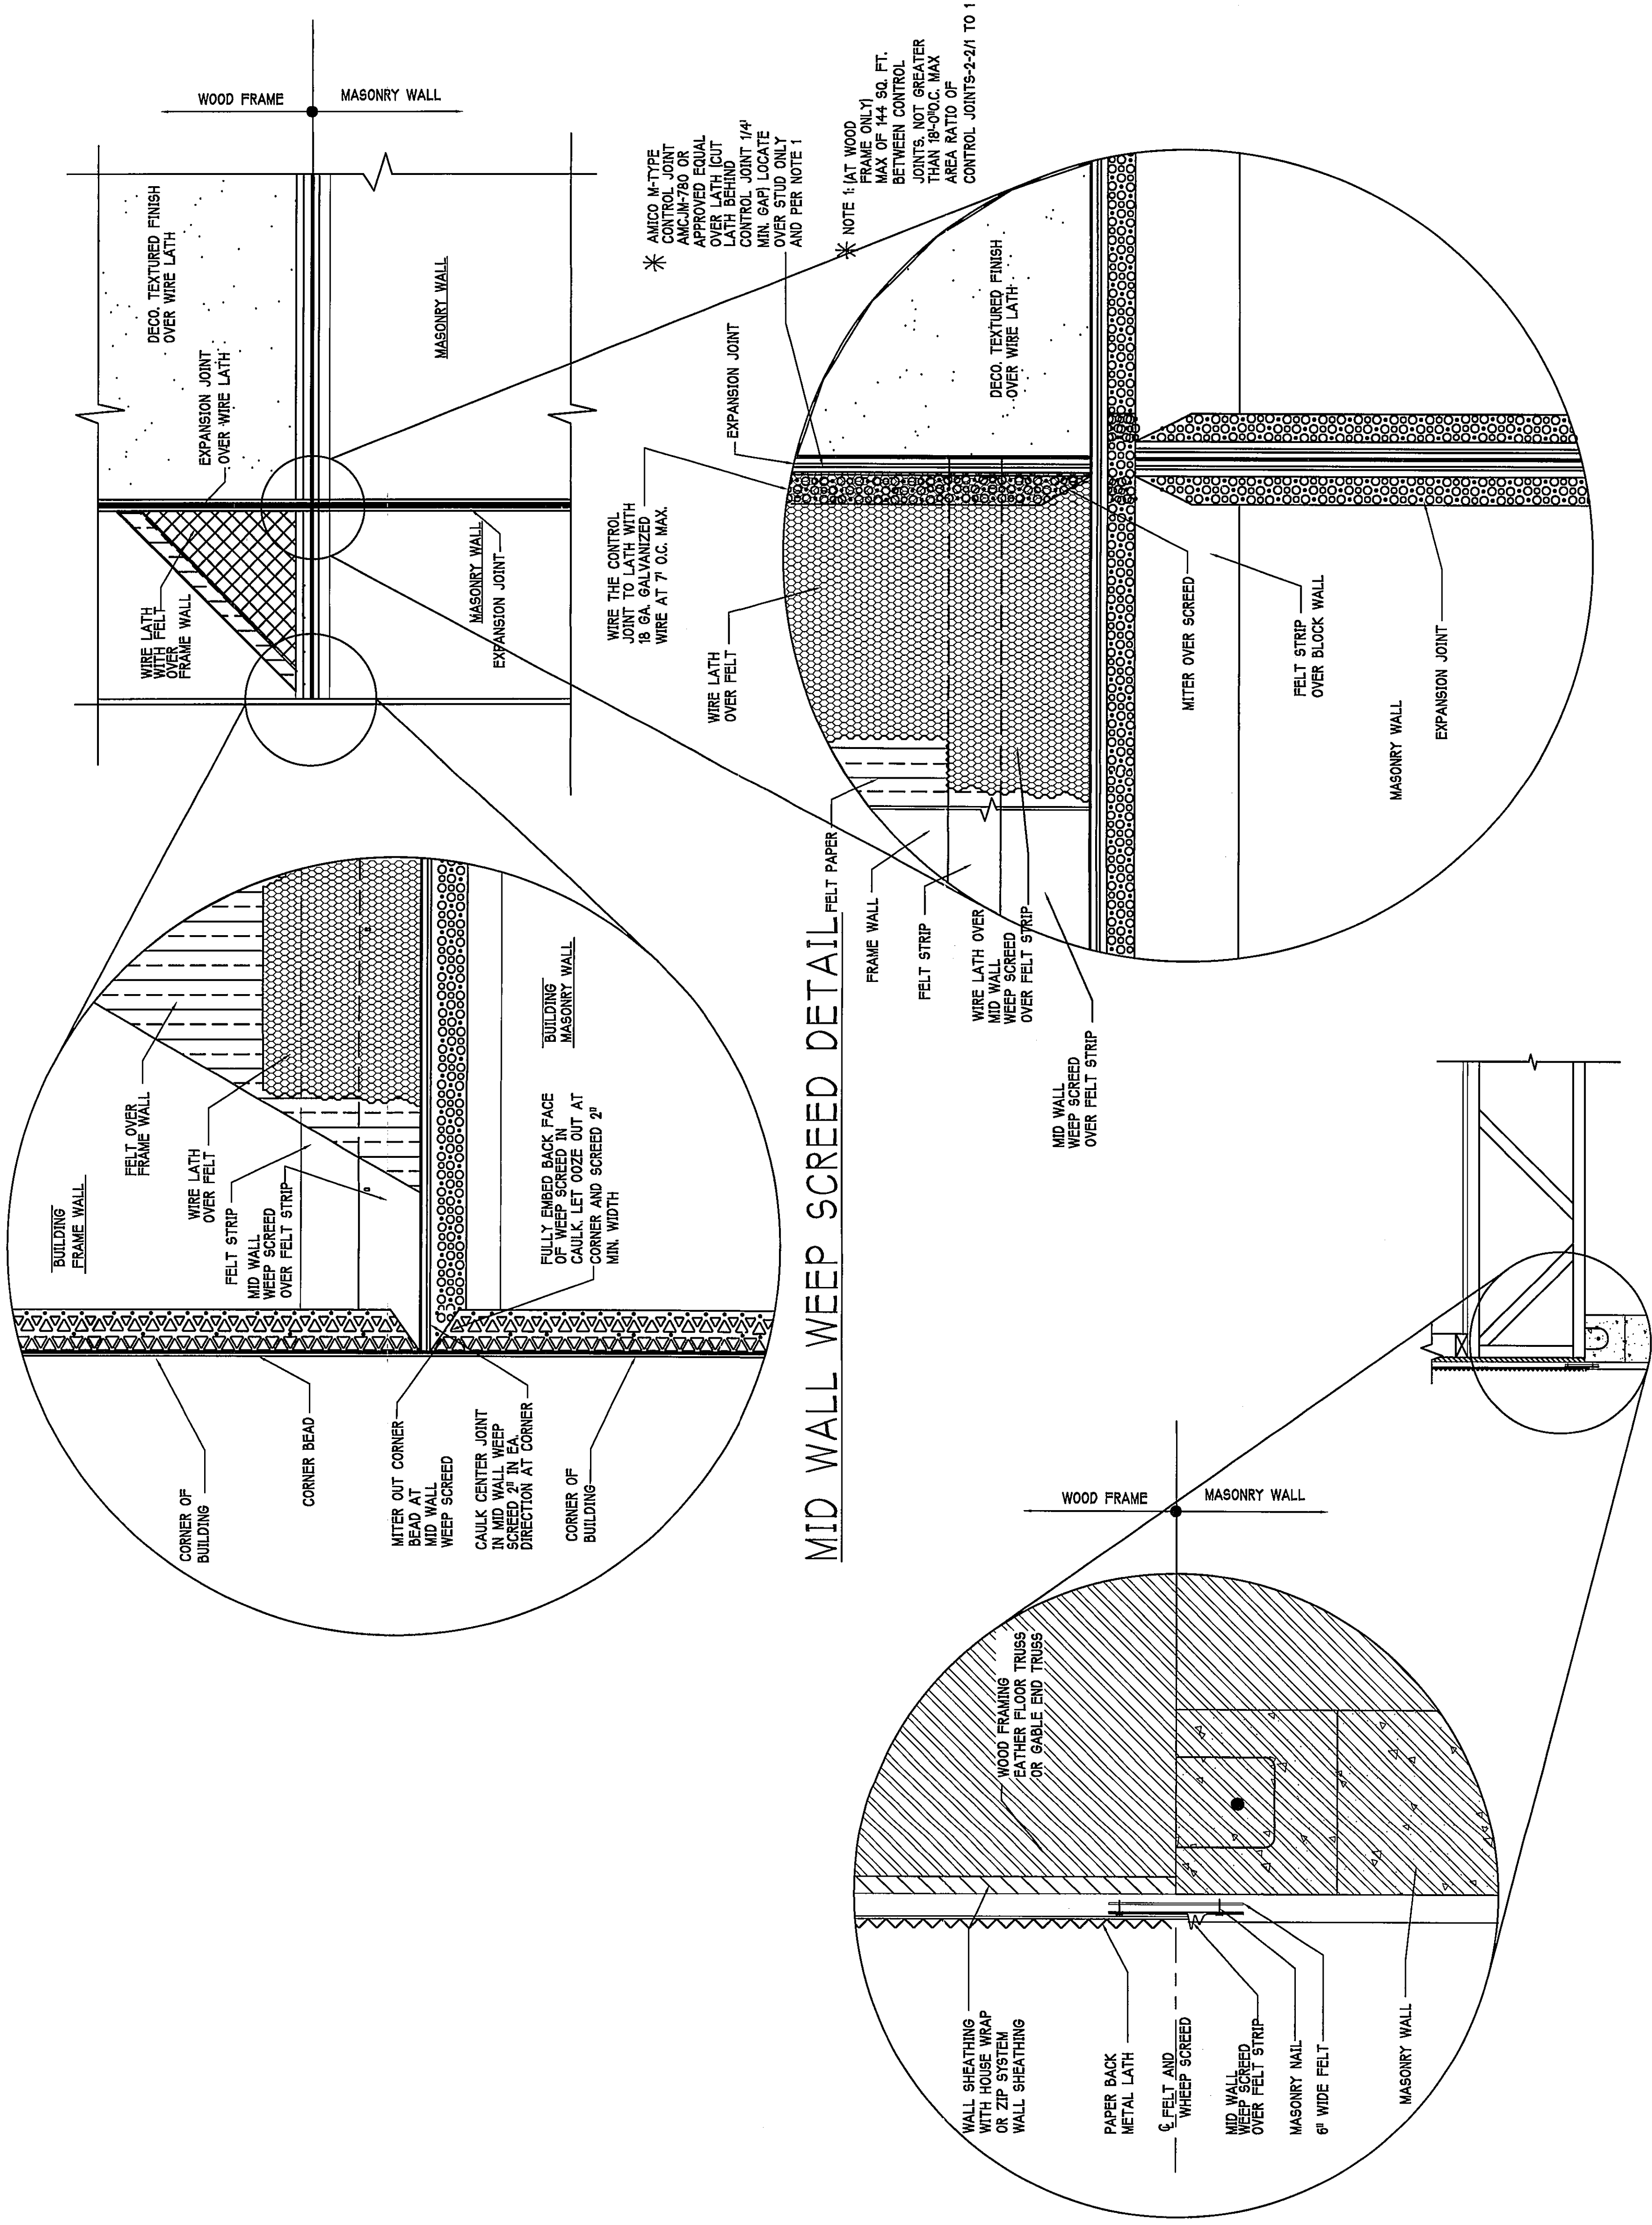

WEEP SCREED DETAIL

INSTALL AT ALL EXTERIOR WALL LOCATIONS WHERE WOOD STUD FRAMING IS ABOVE MASONRY WALLS.

REVIEWED
FOR CODE COMPLIANCE
CAPE CORAL BUILDING DIVISION
BY WJS DATED 8/2/19
ALL CONSTRUCTION SHALL BE IN
COMPLIANCE WITH THE FLORIDA BUILDING
CODE, ALL STATE AND LOCAL CODES. THE
GRANTING OF A PERMIT DOES NOT RELIEVE
THE CONTRACTOR OF RESPONSIBILITY TO
COMPLY WITH ALL GOVERNED ORDINANCES

FOR SCOSTA TRUSSES, ELEVATION B, 3 CAR GARAGE, JOB # 44223B3, DATED: 06/26/14, REVISED: NONE

